


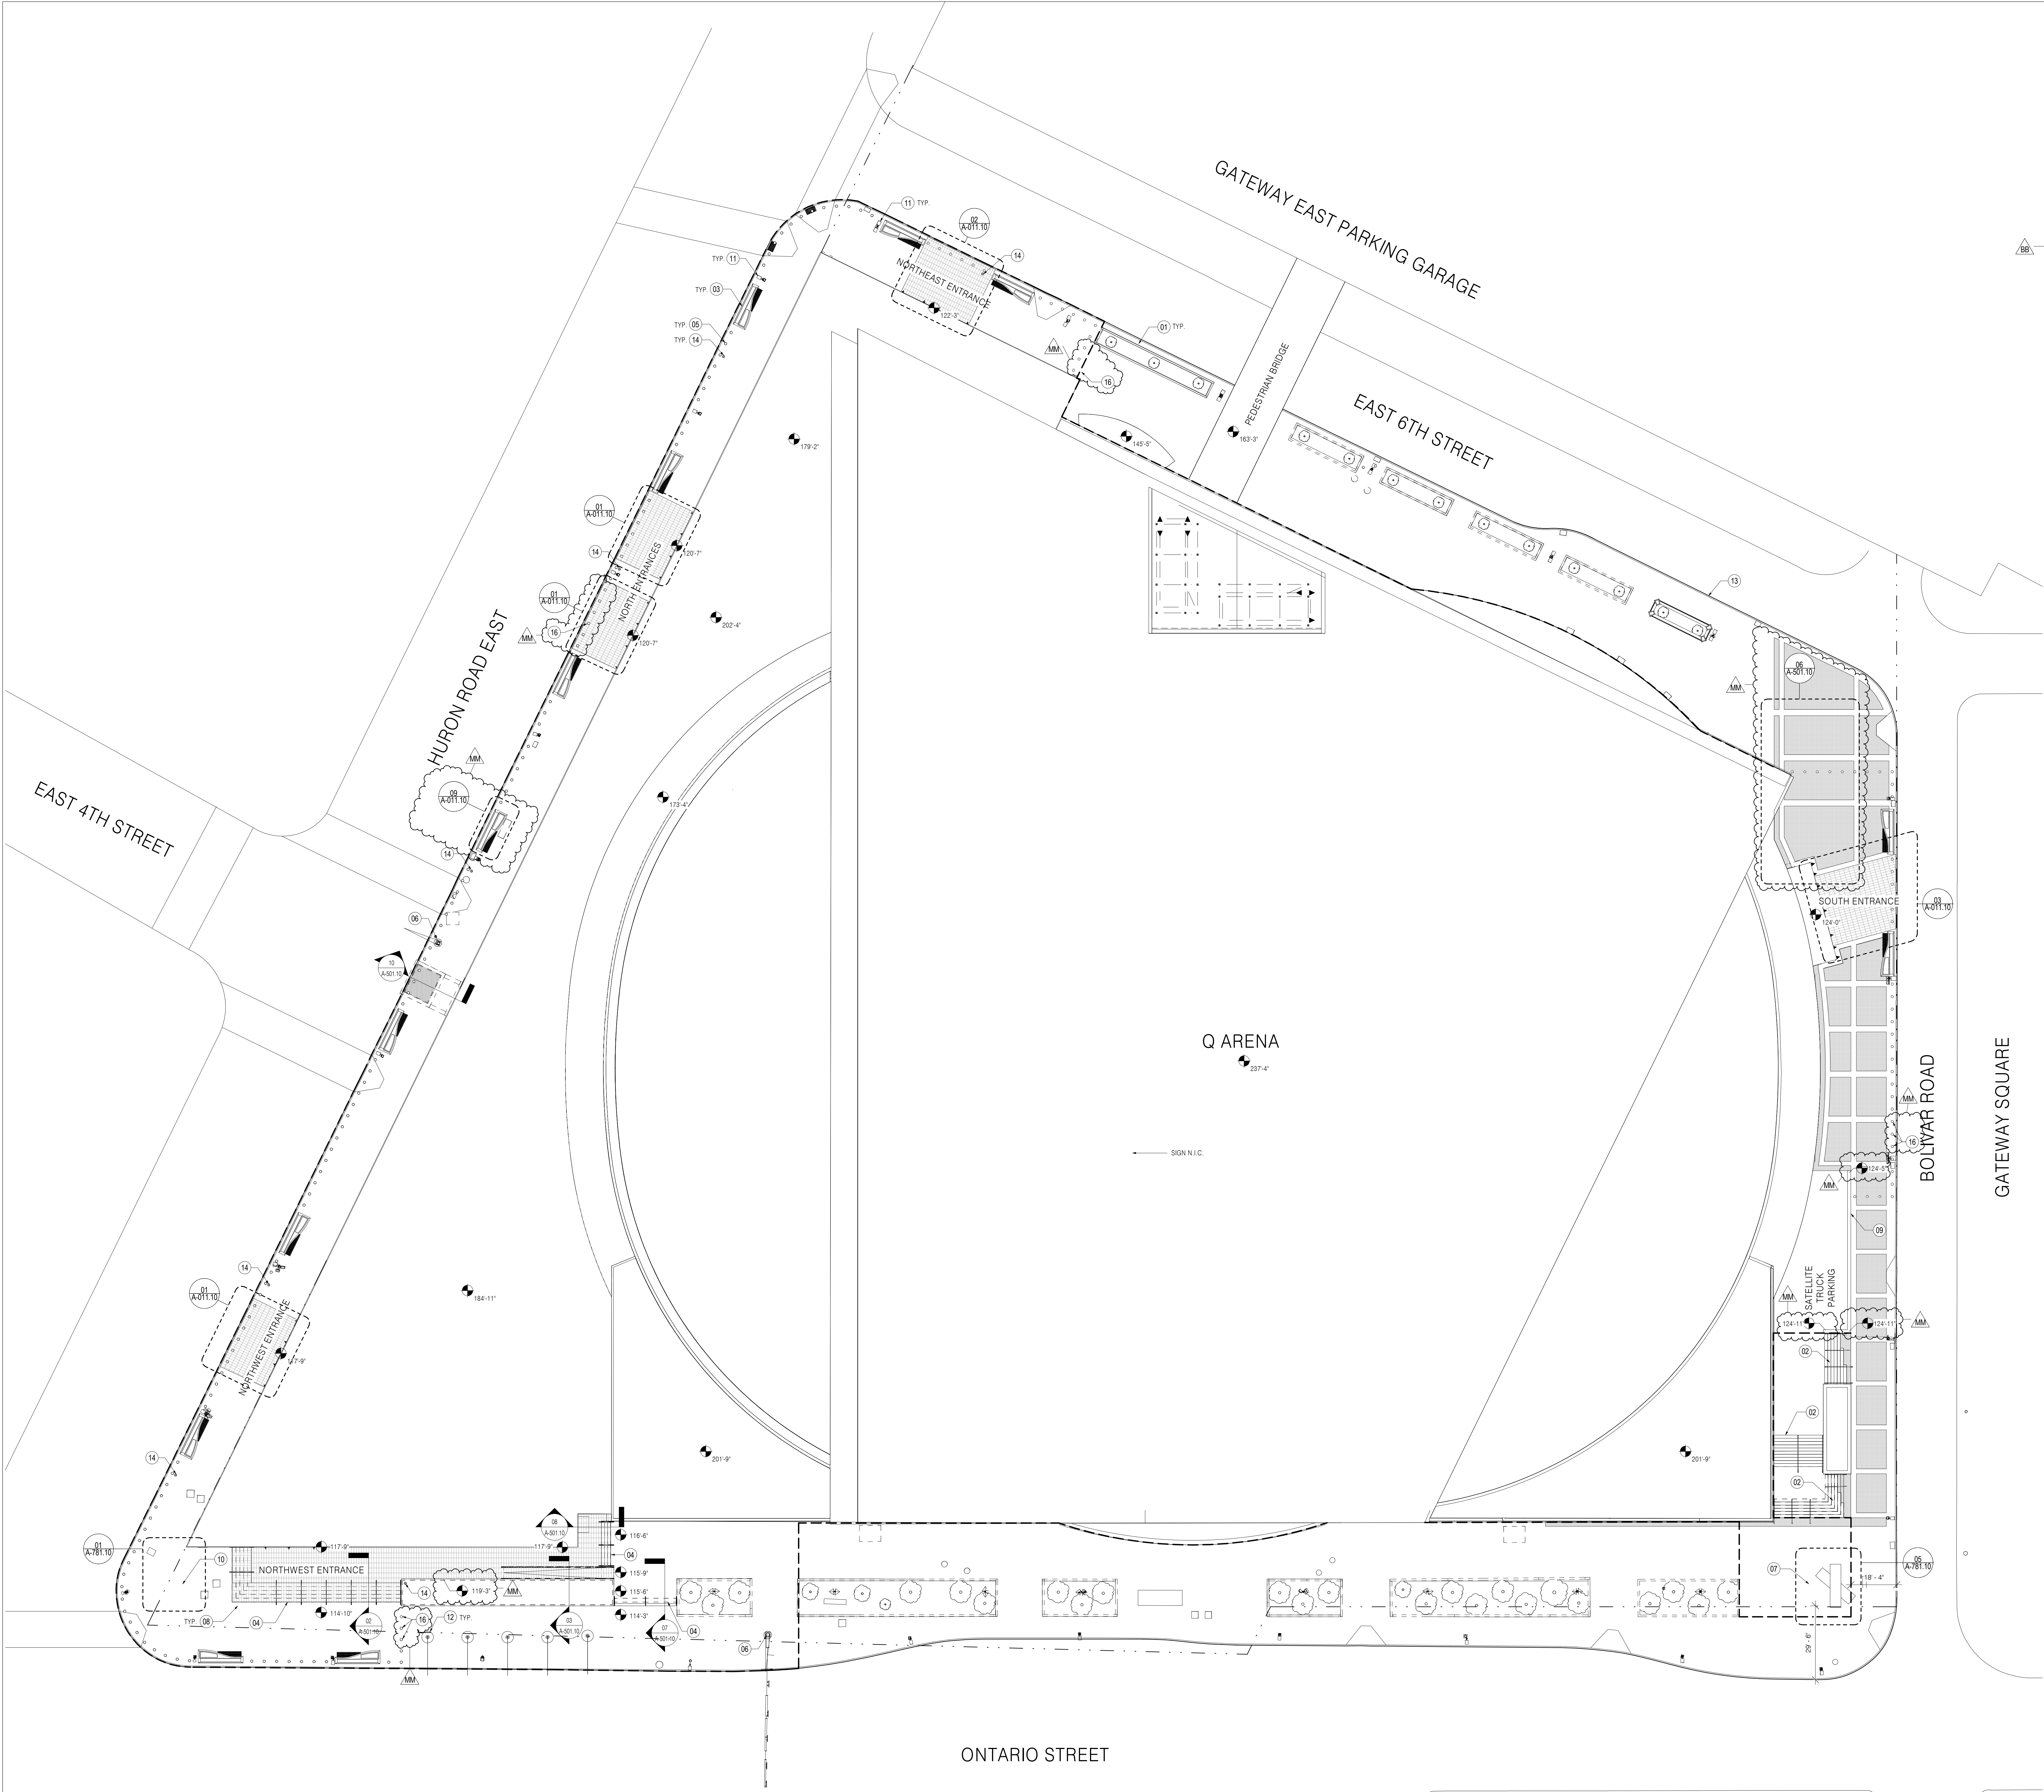

SHEET NOTES

- 01 EXISTING PLANTER
- 02 EXISTING STAIR
- 03 NEW PLANTER BENCH, K-12 RATED
- 04 NEW STAIR
- 05 NEW BOLLARD, K-12 RATED
- 06 EXISTING STREET LIGHT POLE
- 07 NEW 3-TIER LED TOTEM, DYNAMIC SIGNAGE
- 08 PROPERTY LINE
- 09 NEW RETAINING WALL
- 10 NEW FOUNDATION AND INFRASTRUCTURE FOR FUTURE 3-TIER LED TOTEM.
- 11 EXISTING LIGHT POLE
- 12 NEW FLAG POLE
- 13 EXISTING GRANITE CURB
- 14 14' HIGH TECHNOLOGY POLE, SELUX EXELIA COLUMN IN BLACK, PROVIDE WITHOUT LIGHT FIXTURE
- 16 RETRACTABLE BOLLARD, K-12 RATED

GENERAL NOTES

- A. PROJECT LEVELS ARE BASED ON A CRGS DATUM. EVENT LEVEL 01 ELEVATION (100'-0") = 651.00 CRGS, REFER TO SITE SURVEY.
- B. EXTERIOR SLAB ELEVATION AND SLOPE TO BE COORDINATED WITH EXISTING GRADE ALONG ADJACENT STREETS AND SIDEWALKS.
- C. EXISTING SITE HARDSCAPE MATERIAL TO BE REPAIRED AND REPLACED AS NEEDED TO PERFORM THE WORK. REFER TO CIVIL FOR FUTHER INFORMATION.
- D. REFER TO CIVIL FOR FULL SCOPE OF SITEWORKS.
- E. REFER TO CIVIL AND MEP FOR UTILITIES INFORMATION. THE CONTRACTOR SHALL BE RESPONSIBLE FOR COORDINATING BETWEEN ALL TRADES.

LEGEND


- PROPERTY LINE
- LIMIT OF WORK AREA



CAVALIERS OPERATING COMPANY, LLC
1 CENTER COURT
CLEVELAND, OH 44115
44.025.000


Gensler
SPORTS

ARCHITECT	
GENSLER 20014 ST. WAY, SUITE 300 WASHINGTON, DC 20005 Tel: 202.771.3200	
ASSOCIATE ARCHITECT - INTERIORS	
ROBERT P. JACKSON 100 WEST FORTY STREET, SUITE 400 DETROIT, MI 48226 Tel: 313.463.6757	ROBERT P. JACKSON INTERNATIONAL, INC. 2900 EXLUD AVENUE CLEVELAND, OH 44115 Tel: 216.891.8195
STRUCTURAL ENGINEER	
THORNTON TOMASETTI, INC. 21 UNION AVENUE NEW YORK, NY 10010 Tel: 212.687.7000	SMITH BECKMAN REED, INC. 3905 SLOCUM DRIVE NASHVILLE, TN 37204 Tel: 615.380.1113
LIGHTING DESIGNER	
CVI 40 NORTH ST. SUITE 802 NEW YORK, NY 10013 Tel: 212.208.8860	WARM, INC. 504 MCCURT ROAD, SUITE 104 CARROLLTON, TX 75006 Tel: 214.701.8144
CIVIL ENGINEER	
THE C.W. COURTNEY COMPANY 700 BETA DRIVE, SUITE 200 CLEVELAND, OH 44113 Tel: 440.448.4265	ED BROTHER CONSULTING LLC 3900 MISSON BELLEVUE LOUISBURG, KS 66043 Tel: 913.549.8475
LIGHTING (EXTERIOR, SITE, INTERIOR, ACCESSIBILITY)	
OFFICE FOR VISUAL INTERACTION, INC. 40 NORTH STREET, SUITE 802 NEW YORK, NY 10013 Tel: 212.208.8860	CODE CONSULTANTS, INC. 210 WEST 40TH STREET, 10TH FLOOR NEW YORK, NY 10018 Tel: 212.210.8596
TRAFFIC PARKING & PEDESTRIAN MODELING	
CDM SMITH 1400 WEST 5TH STREET SUITE 750 CLEVELAND, OH 44113 Tel: 216.579.9464	THE BOUNDARY LAYER WIND TUNNEL LABORATORY THE UNIVERSITY OF WESTERN ONTARIO LONDON, ON, CANADA N6A 5B9 Tel: 519.993.5338
CIVIL PLANNING	
VERUE SOLUTIONS GROUP 7100 PEACH COURT, SUITE 108 BRIGHTFORD, TN 37027 Tel: 615.352.6484	FOOD SERVICES THE BECKLOW COMPANY, INC. 801 EAST COMMERCE AVENUE KANSAS CITY, MO 64102 Tel: 816.483.8533
VERTICAL TRANSPORTATION	
VAN DEUSEN & ASSOCIATES 120 EAGLE ROCK AVENUE, SUITE 310 EAST HANOVER, NJ 07936 Tel: 973.994.6222	BRANDING & WAYFINDING INFINITE SCALE 16 EXCHANGE PLACE SALT LAKE CITY, UT 84111 Tel: 801.363.1881

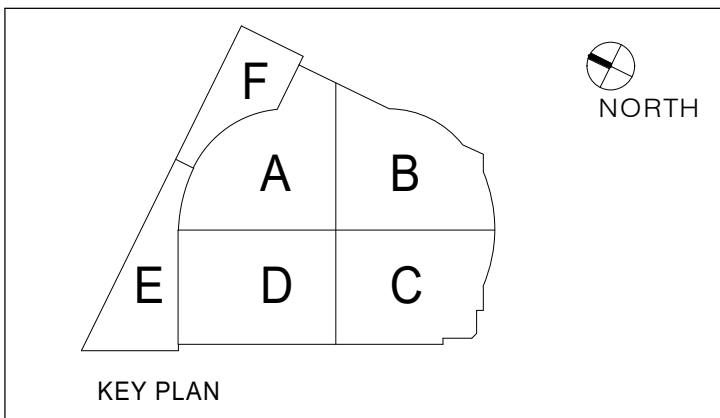

MM	ADDENDUM 33 - PACKAGE 10	09/28/18
BB	ADDENDUM 23 - PACKAGE 10	06/29/18
19	PKGS 10 - ISSUE FOR PERMIT	06/06/18
REVISION	ISSUE	DATE
DRAWING TITLE		
ARCHITECTURAL SITE PLAN		
SEAL & SIGNATURE		
DATE	04/18/18	
PROJECT NO.	09.8750.100	
DRAWN BY	DG	
CHECKED BY	PS	
DATE		
DRAWING NUMBER		

A-010.10

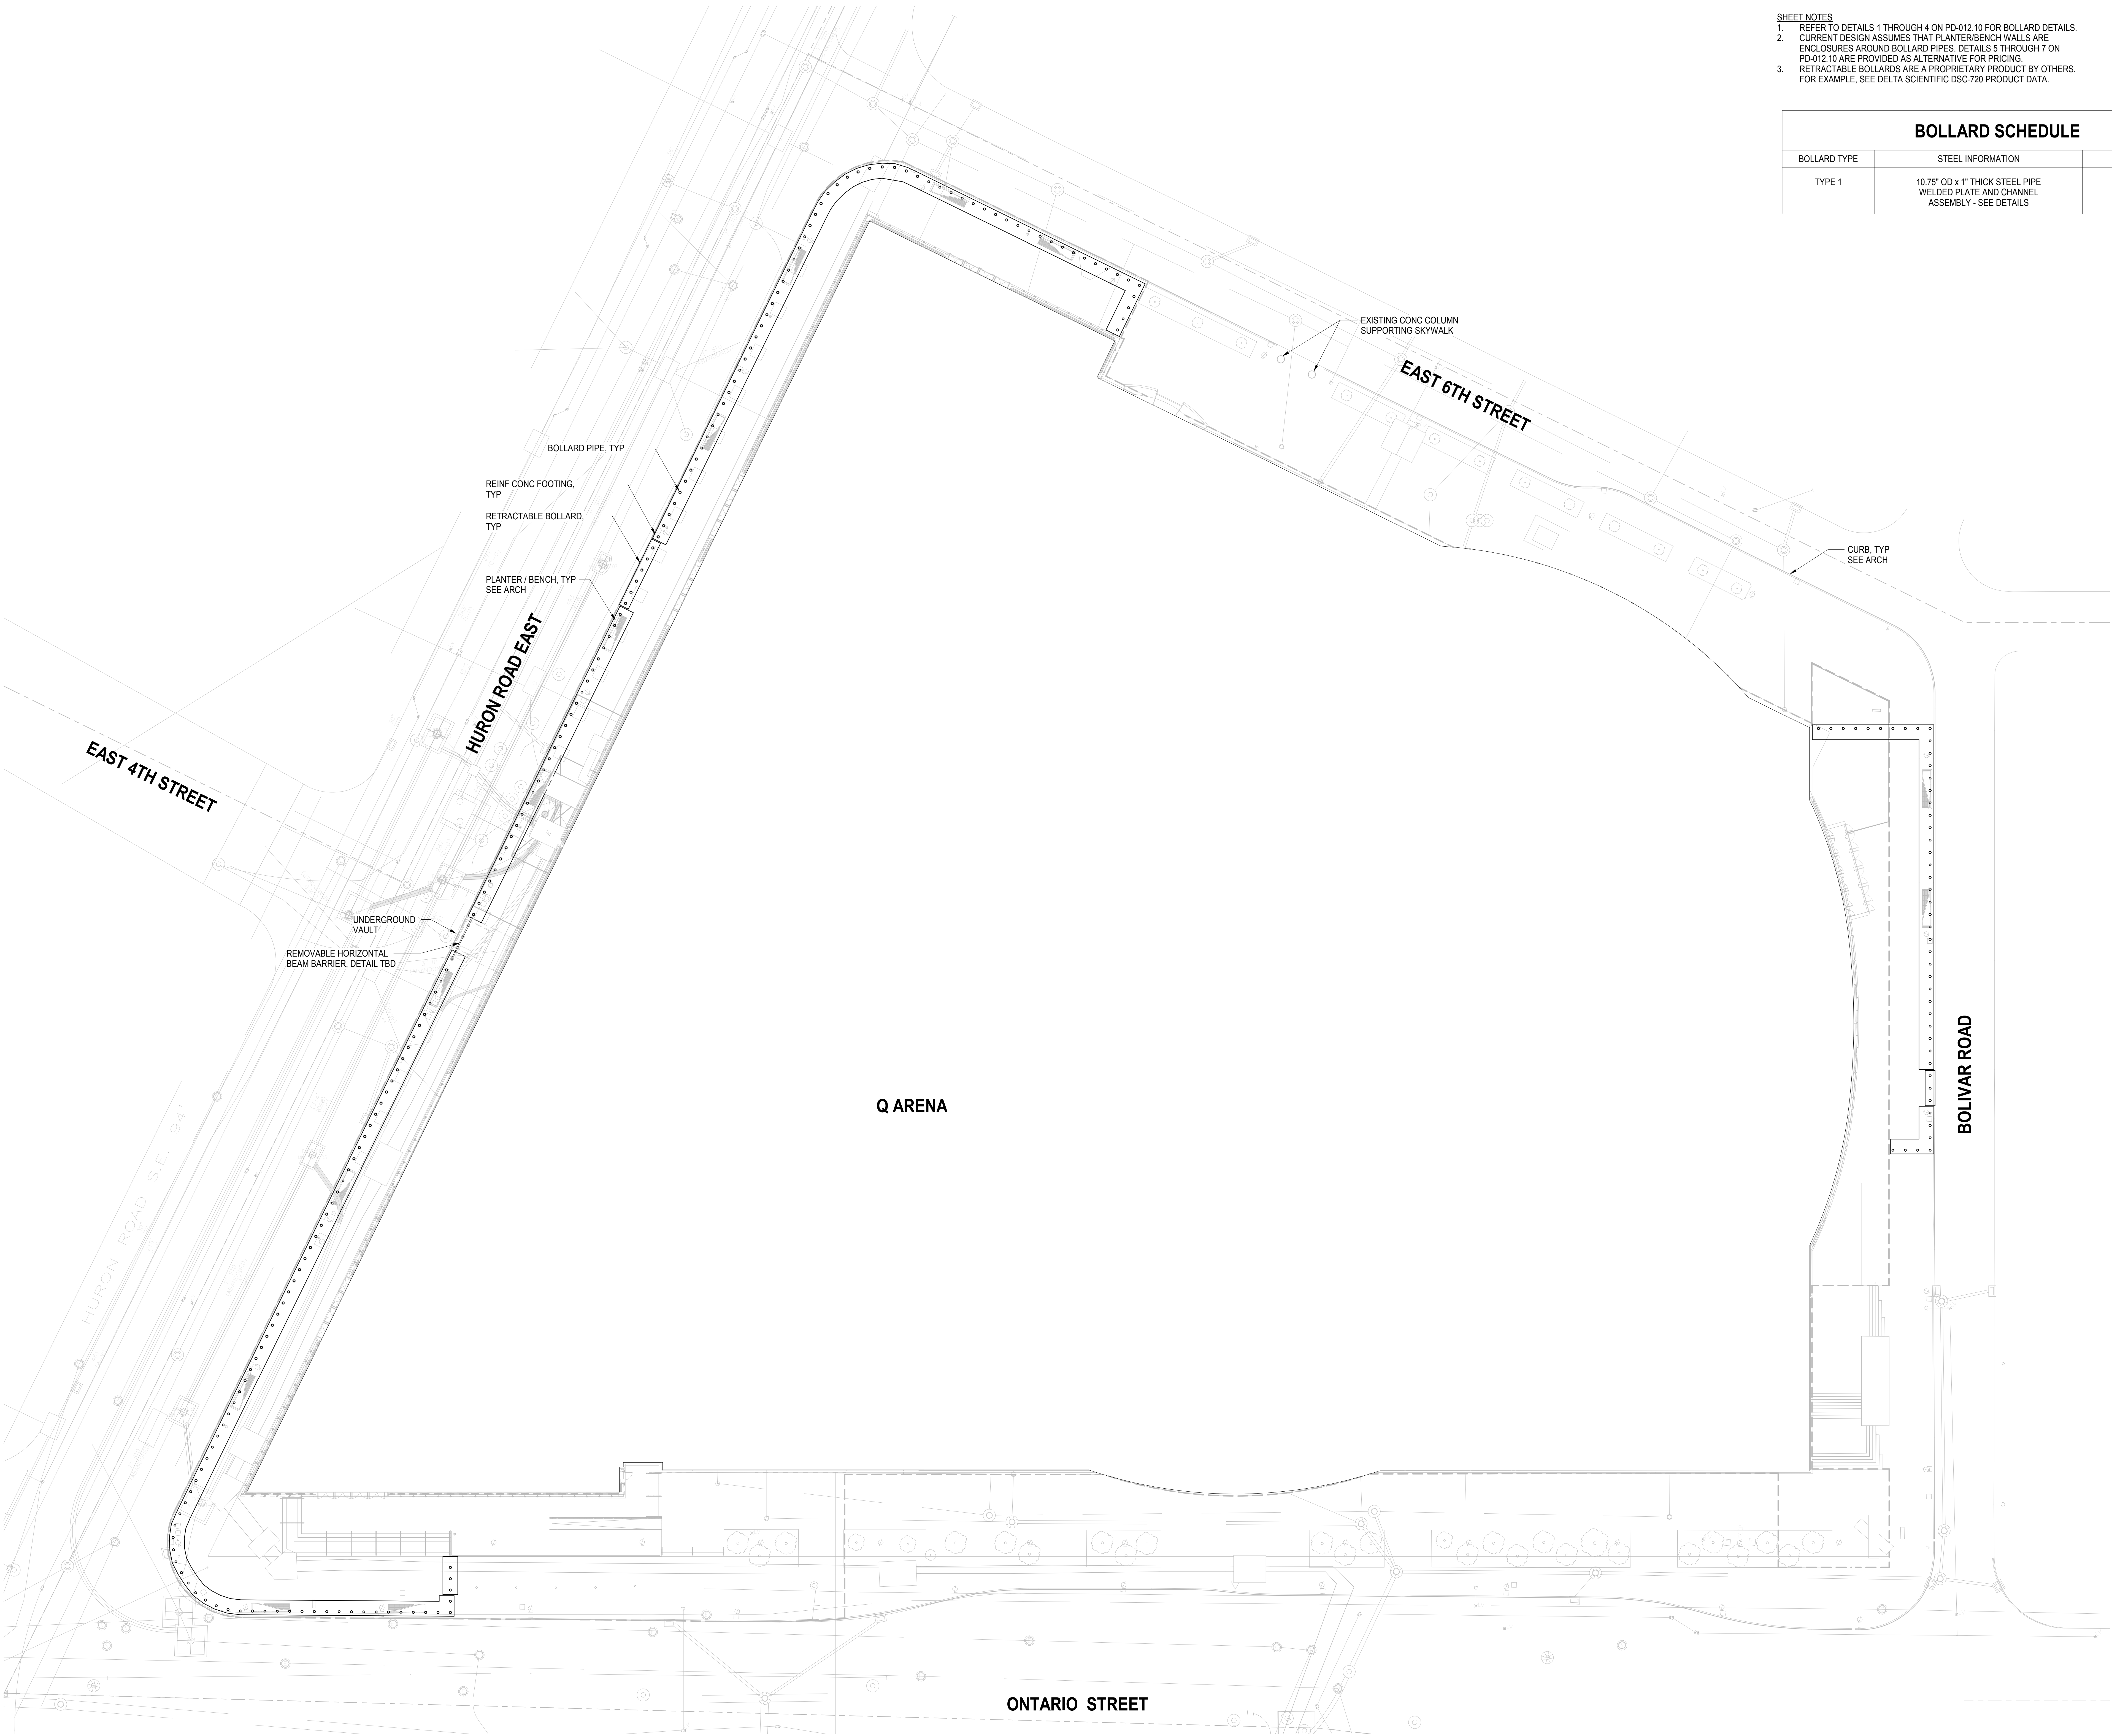

- SHEET NOTES
1. REFER TO DETAILS 1 THROUGH 4 ON PD-012.10 FOR BOLLARD DETAILS.
 2. CURRENT DESIGN ASSUMES THAT PLANTER/BENCH WALLS ARE ENCLOSURES AROUND BOLLARD PIPES. DETAILS 5 THROUGH 7 ON PD-012.10 ARE PROVIDED AS ALTERNATIVE FOR PRICING.
 3. RETRACTABLE BOLLARDS ARE A PROPRIETARY PRODUCT BY OTHERS. FOR EXAMPLE, SEE DELTA SCIENTIFIC DSC-720 PRODUCT DATA.

BOLLARD SCHEDULE		
BOLLARD TYPE	STEEL INFORMATION	DETAIL
TYPE 1	10.75" OD X 1" THICK STEEL PIPE WELDED PLATE AND CHANNEL ASSEMBLY - SEE DETAILS	1/PD-012.10



CAVALIERS OPERATING COMPANY, LLC
1 COUNTRY COURT
CLEVELAND, OH 44115
646.625.3693

Gensler

S P O R T S


ARCHITECT GENSLER 200 K ST NW, SUITE 200 WASHINGTON, DC 20008 Tel: 202.721.5000	
ASSOCIATE ARCHITECT - INTERIORS ROSBETT 160 WEST FORT STREET, SUITE 400 DETROIT, MI 48226 Tel: 313.463.5151	LOCAL ARCHITECTURAL CONSULTANT KA, INC. 1466 WEST 8TH STREET #600 CLEVELAND, OH 44115 Tel: 216.781.9144
STRUCTURAL ENGINEER THORNTON TOMASETTI 51 MADISON AVENUE NEW YORK, NY 10015-1803 Tel: 917.867.7800 Tel: 212.681.8195	LOCAL ARCHITECTURAL CONSULTANT ROBERT F. MADSON INTERNATIONAL, INC. 2800 ELLIOT AVENUE CLEVELAND, OH 44115 Tel: 216.589.8195
MERPP ENGINEER & LIGHTING (SPORTS) SMITH DESIGN REEL, INC. 2805 SISCO DRIVE NASHVILLE, TN 37204 Tel: 615.383.1113	ACOUSTIC ENGINEER & TAV/ ELECTRONIC SOUND CONSULTANT WAVV, INC. 3424 MIDCOURT ROAD, SUITE 124 CARROLLTON, TX 75006 Tel: 214.781.9144
CIVIL ENGINEER THE CIVIL COURTESY COMPANY 700 BETA DRIVE, SUITE 200 CLEVELAND, OH 44113 Tel: 440.449.4005	ACCESSIBILITY ED RUTHER CONSULTING, LLC 25600 MIDSON BELLEVUE LOS ANGELES, CA 90033 Tel: 913.540.9479
LIGHTING (EXTERIOR, SITE, INTERIOR, LUMINAIRE) OFFICE FOR VISUAL INTERACTION, INC. 40 WORTH STREET, SUITE 602 NEW YORK, NY 10013 Tel: 212.208.0800	CODE CONSULTING, FIRE & LIFE SAFETY CODE CONSULTANTS, INC. 215 WEST 40TH STREET, 15TH FLOOR NEW YORK, NY 10018 Tel: 212.216.9999
TRAFFIC, PARKING & PEDESTRIAN ANALYSIS CSM SMITH 1449 WEST 8TH STREET, SUITE 150 CLEVELAND, OH 44113 Tel: 216.579.0404	WIND TUNNEL & SNOW ANALYSIS THE BOUNDARY LAYER WIND TUNNEL LABORATORY THE UNIVERSITY OF WESTERN ONTARIO LONDON, ON, CANADA N6A 5B9 Tel: 519.661.3338
EVENT PLANNING VENUE SOLUTIONS GROUP 7700 PACH COAST, SUITE 108 BENTLEYWOOD, TN 37027 Tel: 615.322.5494	FOOD SERVICES THE BRISQON COMPANIES, INC. 800 EAST COMMERCE AVENUE, SUITE 101 KANSAS CITY, MO 64120 Tel: 816.462.5533
VERTICAL TRANSPORTATION VAN DER BEEK & ASSOCIATES 120 EAGLE ROCK AVENUE, SUITE 310 EAST MANASSAS, VA 20108 Tel: 973.844.6220	PROTECTIVE DESIGN ENGINEER THORNTON TOMASETTI 300 N. WABASH AVENUE, SUITE 1500 CHICAGO, IL 60611-7622 Tel: 312.596.2000



NOT FOR
CONSTRUCTION


SCHEMATIC DESIGN	09/14/2018
ISSUE	DATE
DRAWING TITLE	
OVERALL SITE PLAN	
SEAL & SIGNATURE	DATE 09/14/2018
PROJECT NO.	C18172.00
DRAWN BY	NS
CHECKED BY	TMD
DRAWING NO.	
DRAWING NUMBER	

PD-010.10

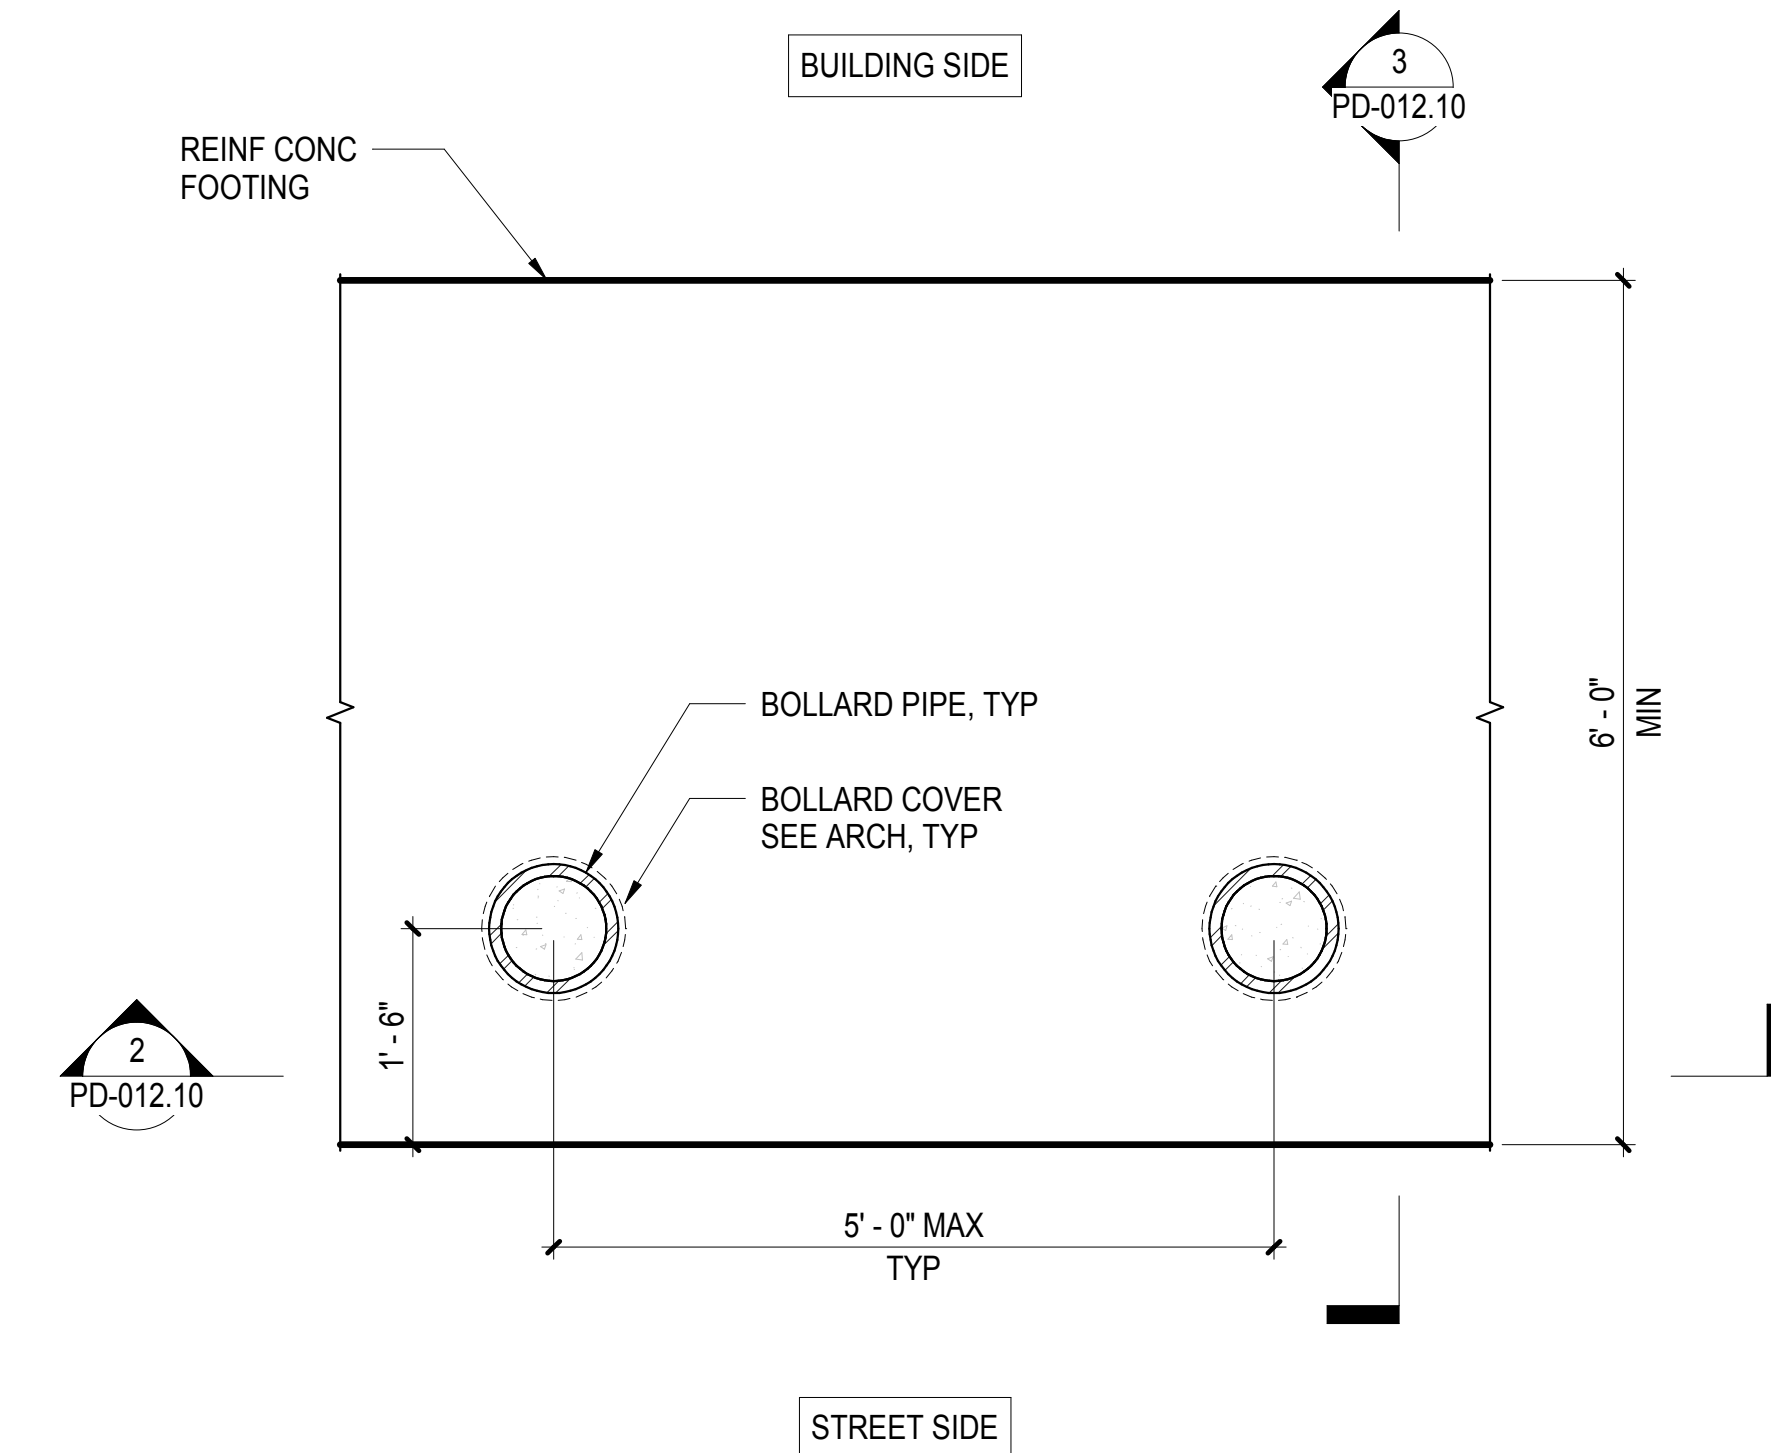

1 SHALLOW FOOTING DETAIL


SCALE: 3/4" = 1'-0"

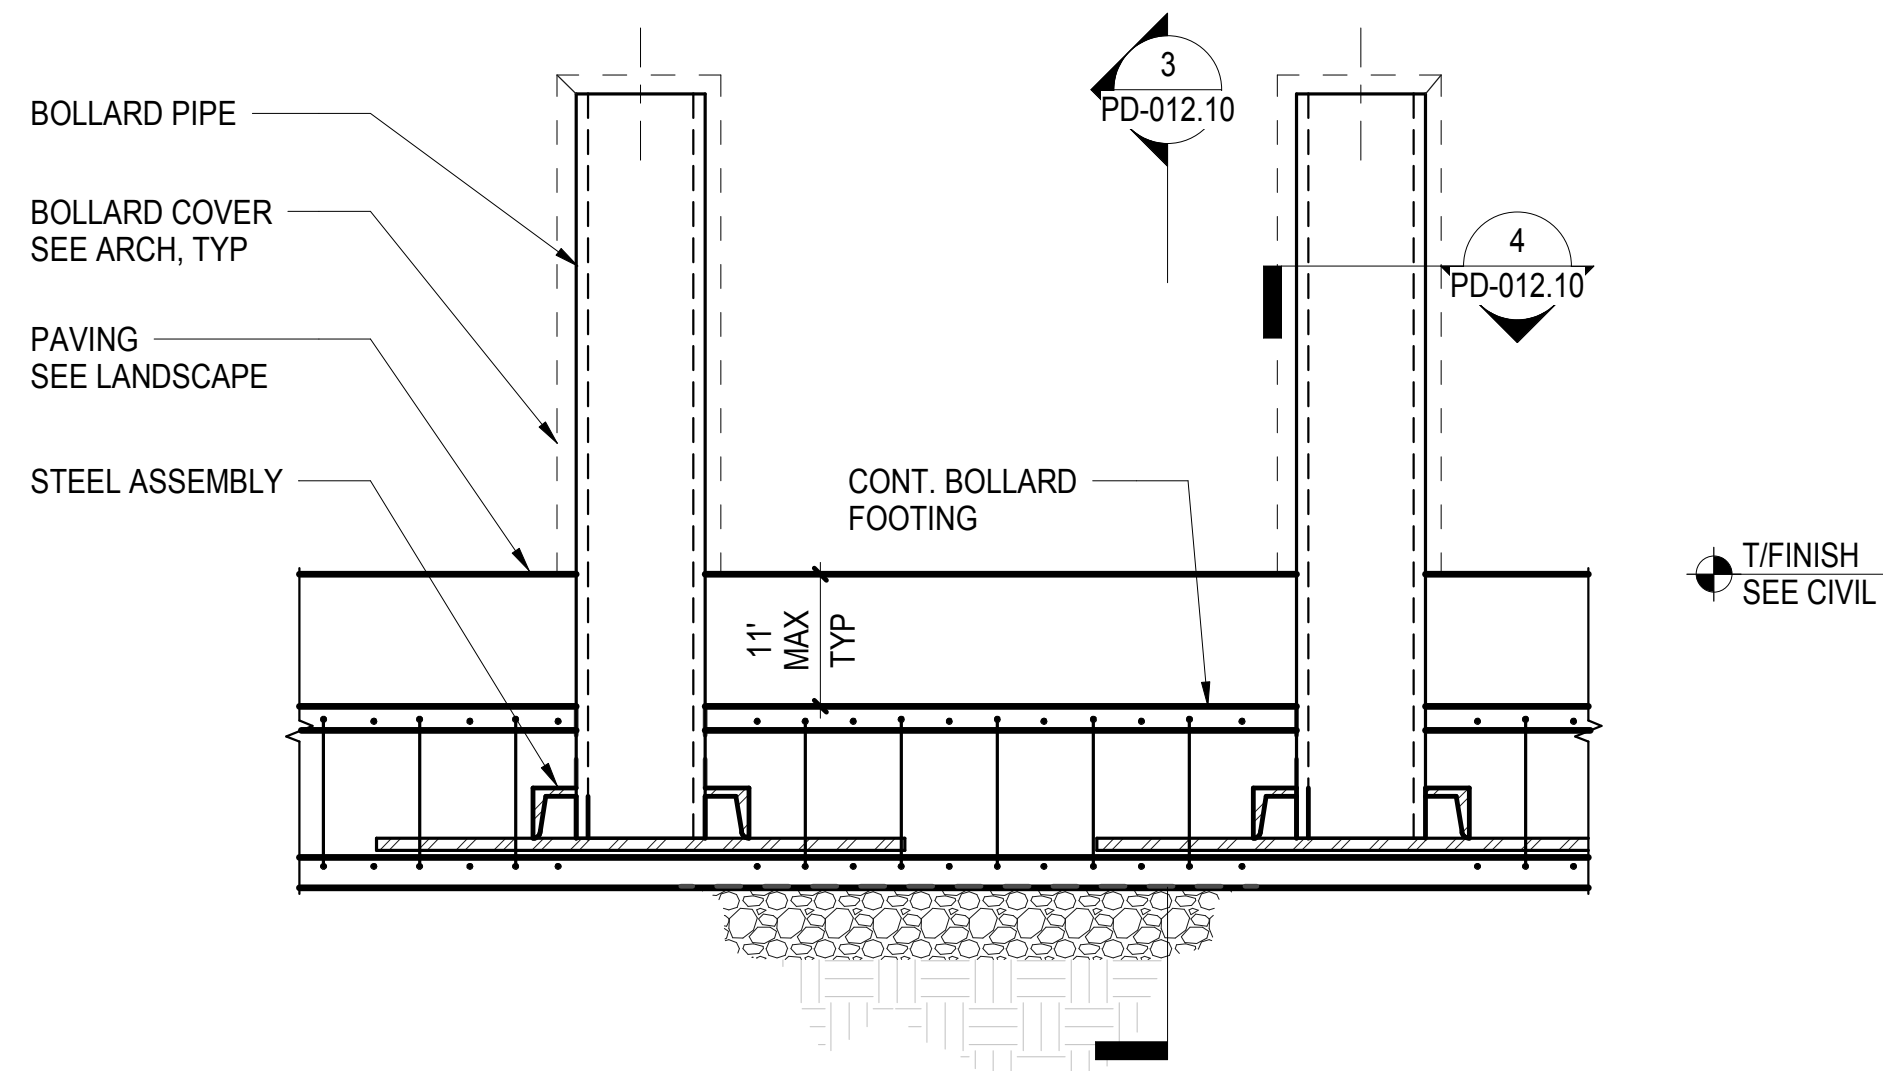

NOTES
1. 135 DEG HOOKS FOR STIRRUPS TO ALTERNATE BETWEEN FRONT AND BACK OF FOUNDATION AT EVERY STIRRUP.

2 SHALLOW FOOTING ELEVATION


SCALE: 3/4" = 1'-0"

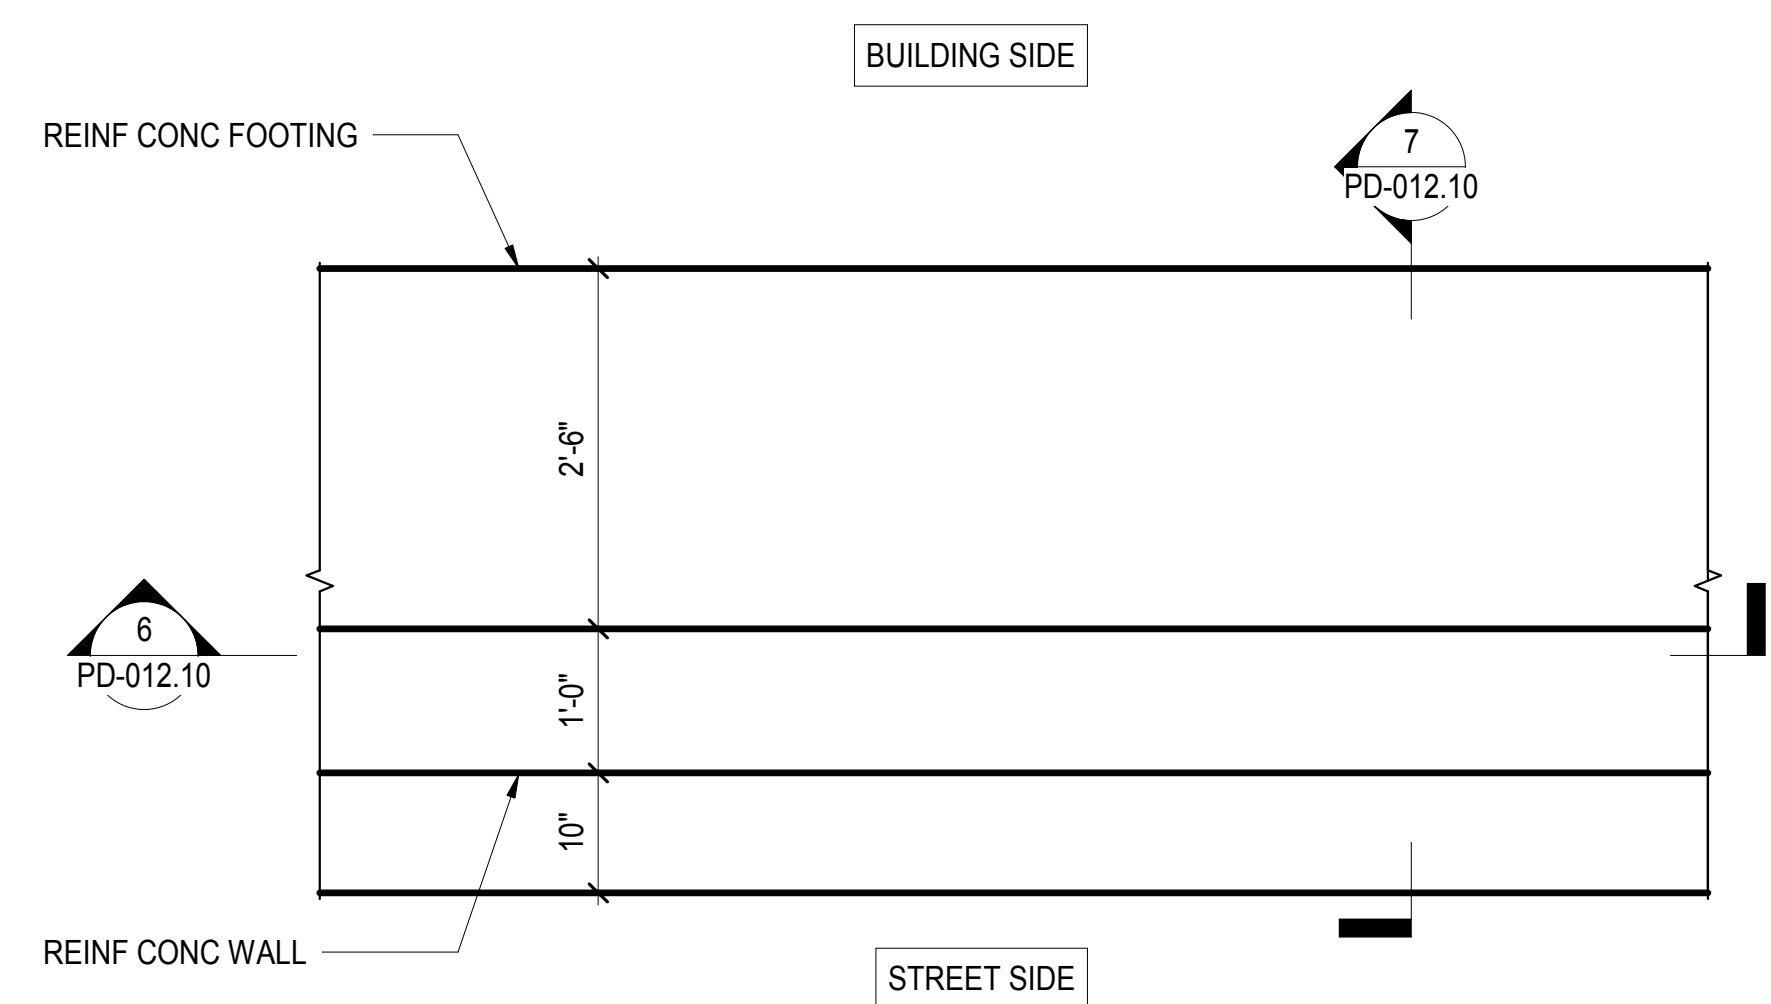

NOTES
1. OPTION 2 AT PLANTER/BENCH WALLS. SEE 1/PD012.10 FOR OPTION 1 AT THESE LOCATIONS.


5 ANTI-RAM WALL DETAIL

SCALE: 3/4" = 1'-0"

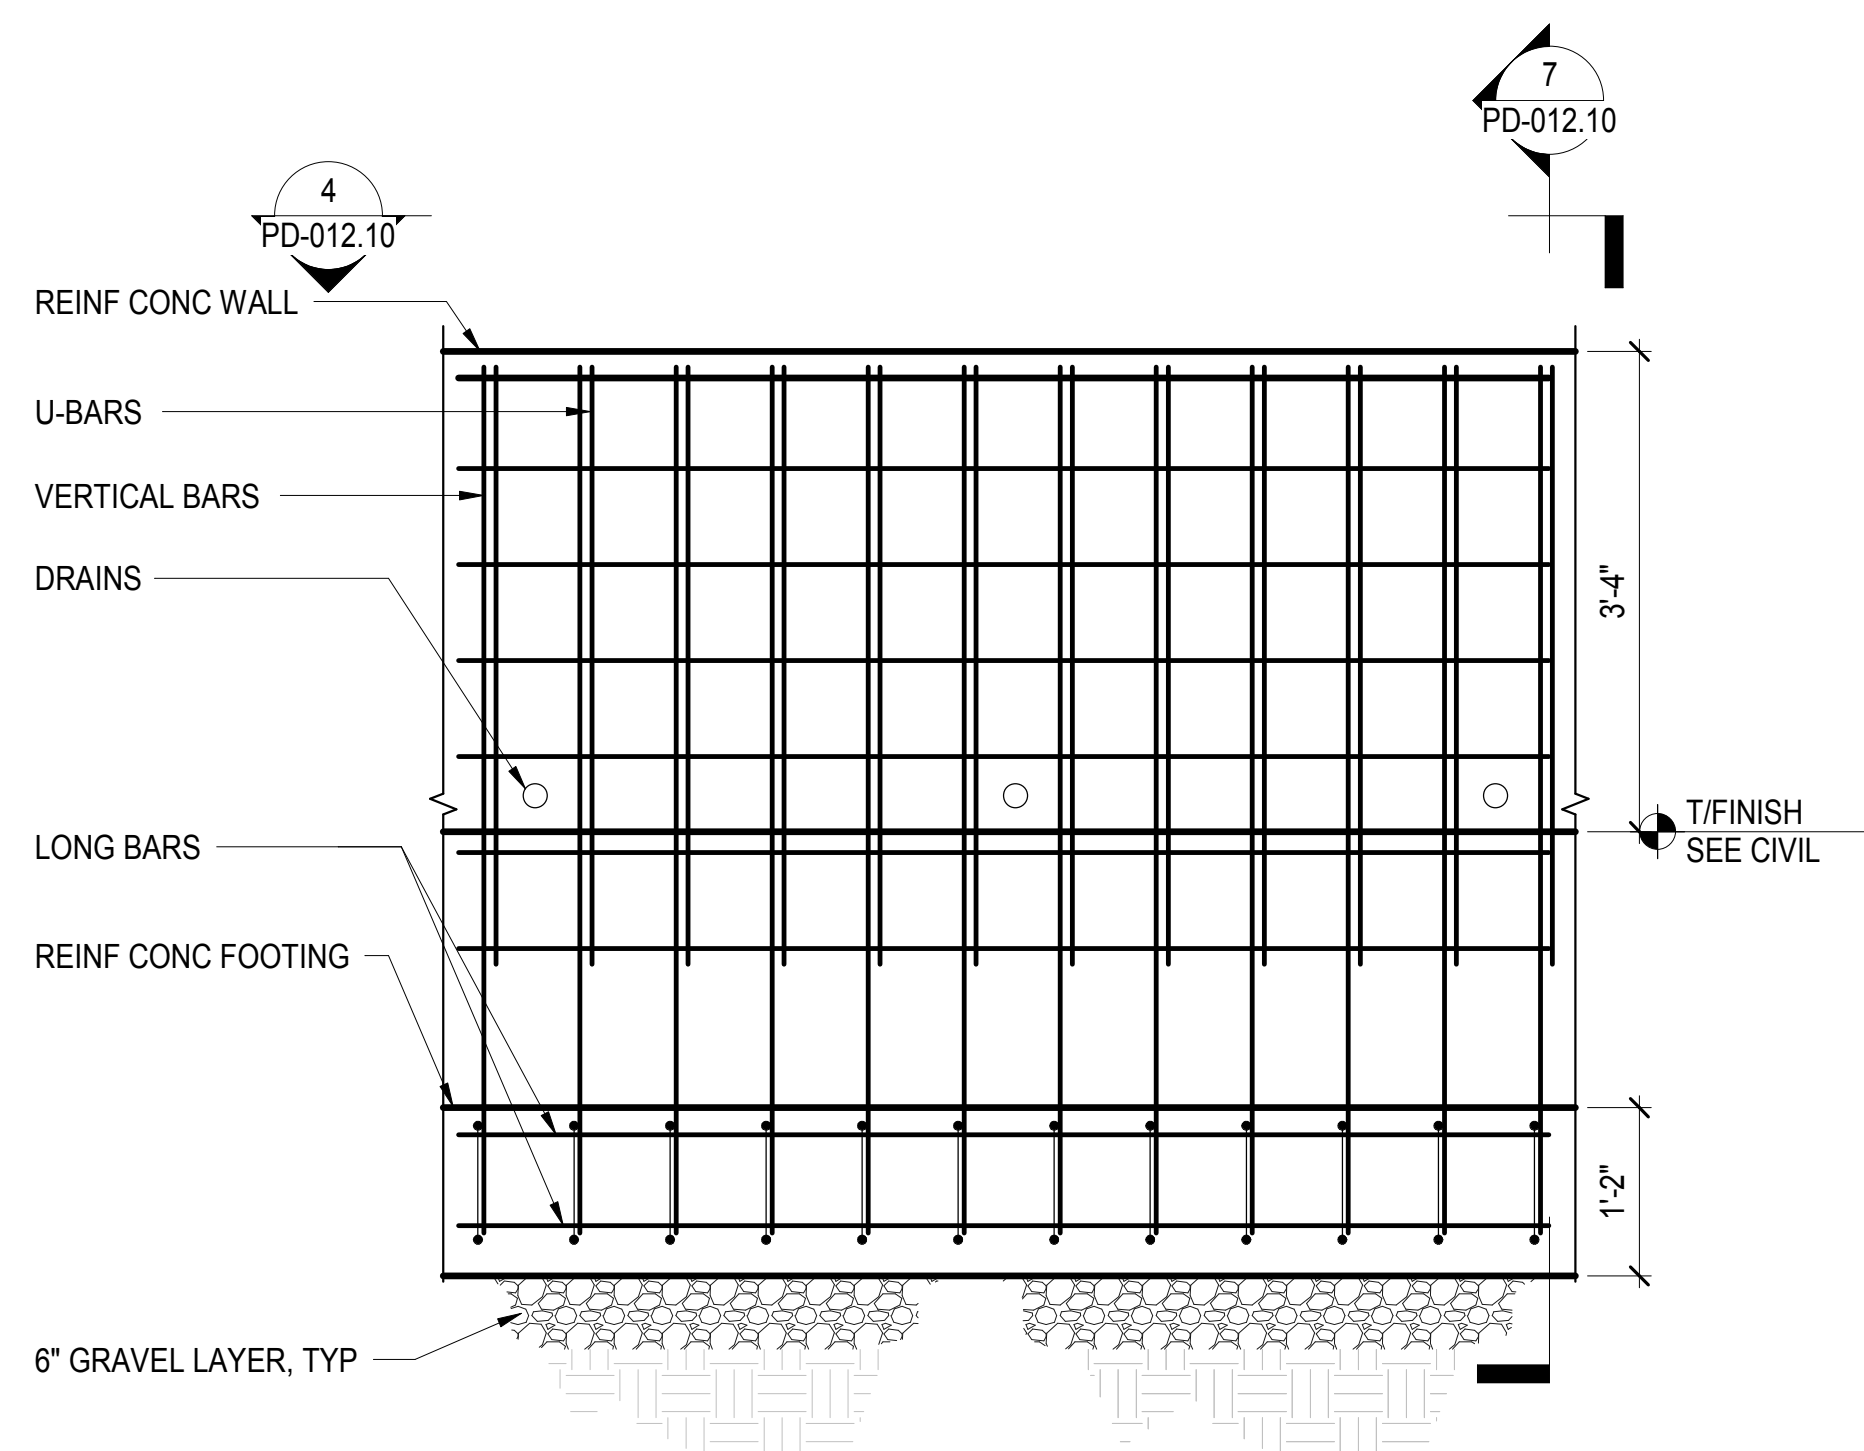

6 ANTI-RAM WALL ELEVATION


SCALE: 3/4" = 1'-0"

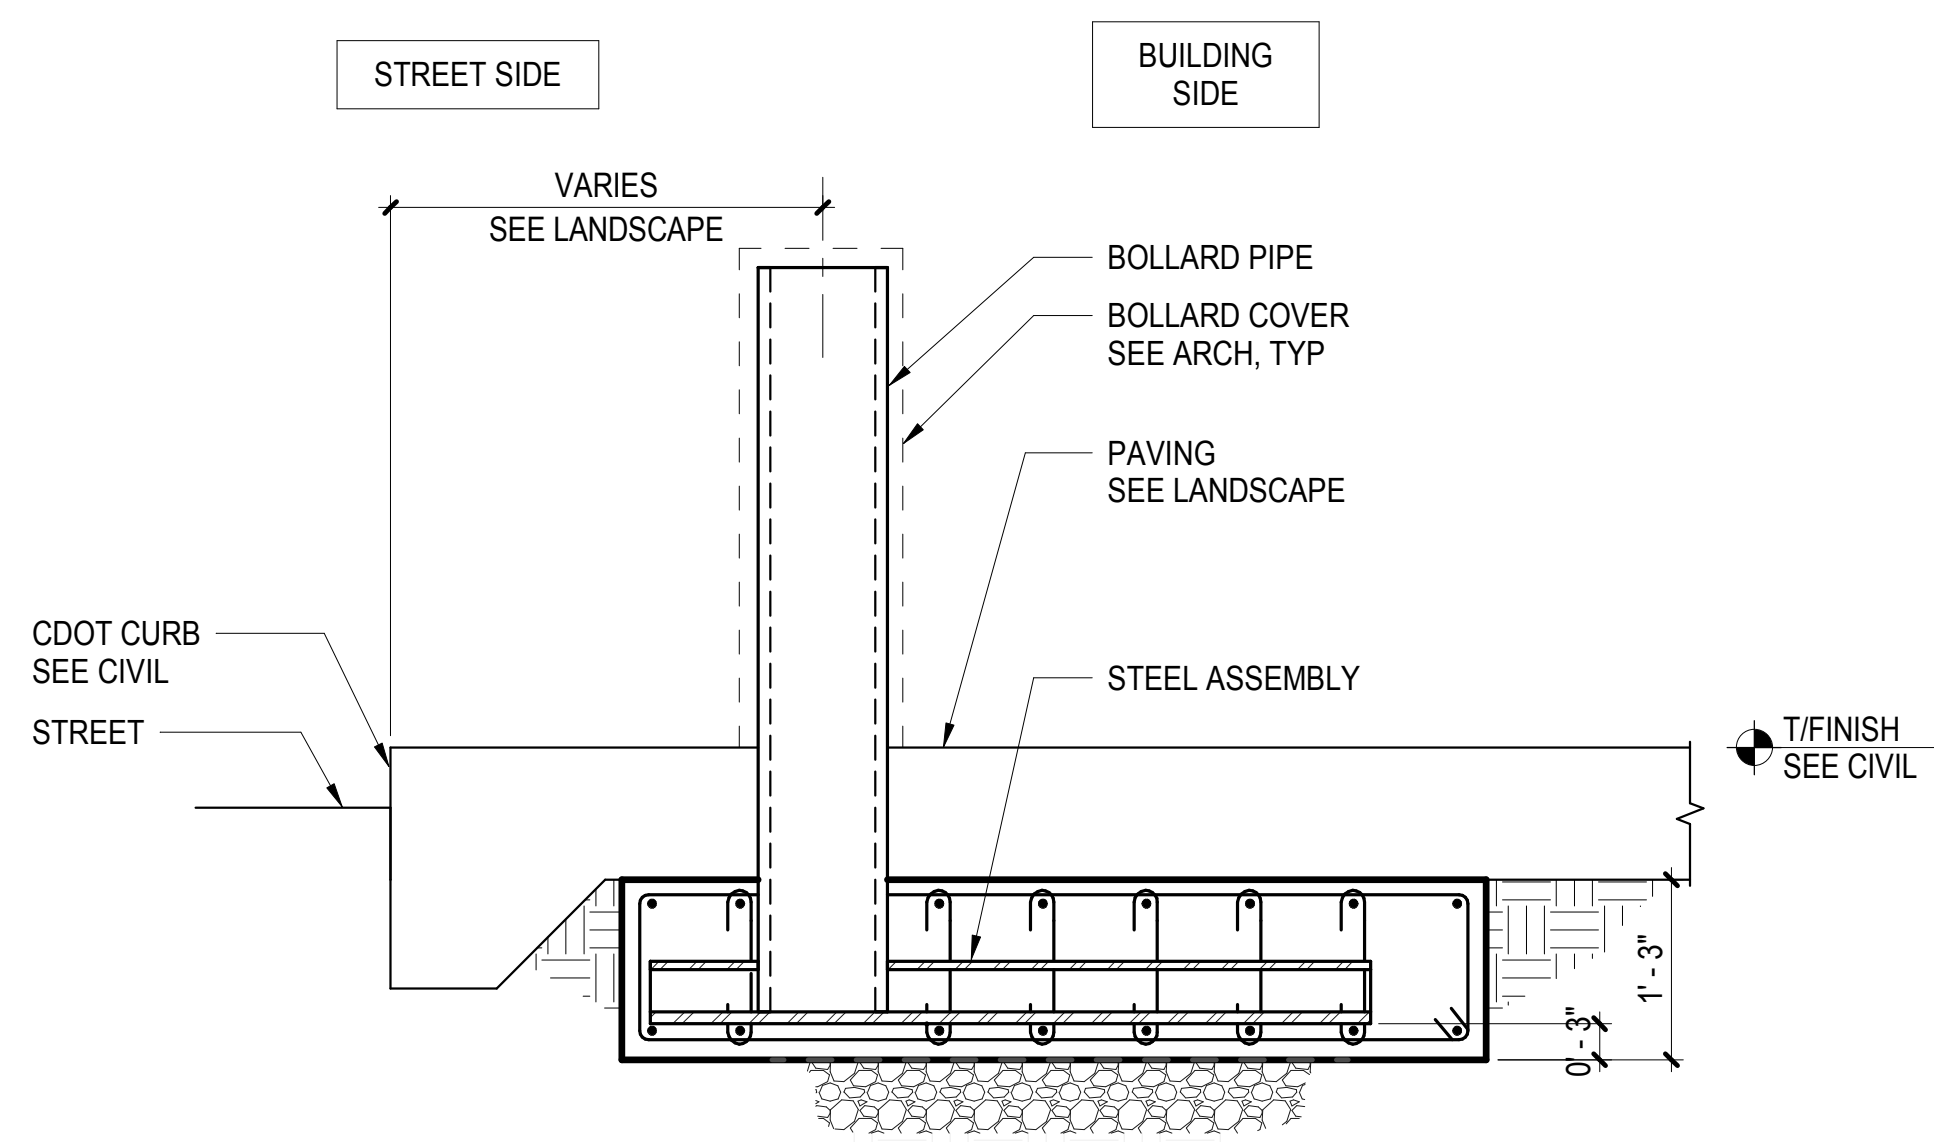

NOTES
1. OPTION 1 AT PLANTER/BENCH WALLS IS TO APPLY ARCHITECTURAL WALL COVER OVER BOLLARD PIPES. SEE 5/PD-012.10 FOR OPTION 2 AT THESE LOCATIONS.


3 SHALLOW FOOTING SECTION

SCALE: 3/4" = 1'-0"

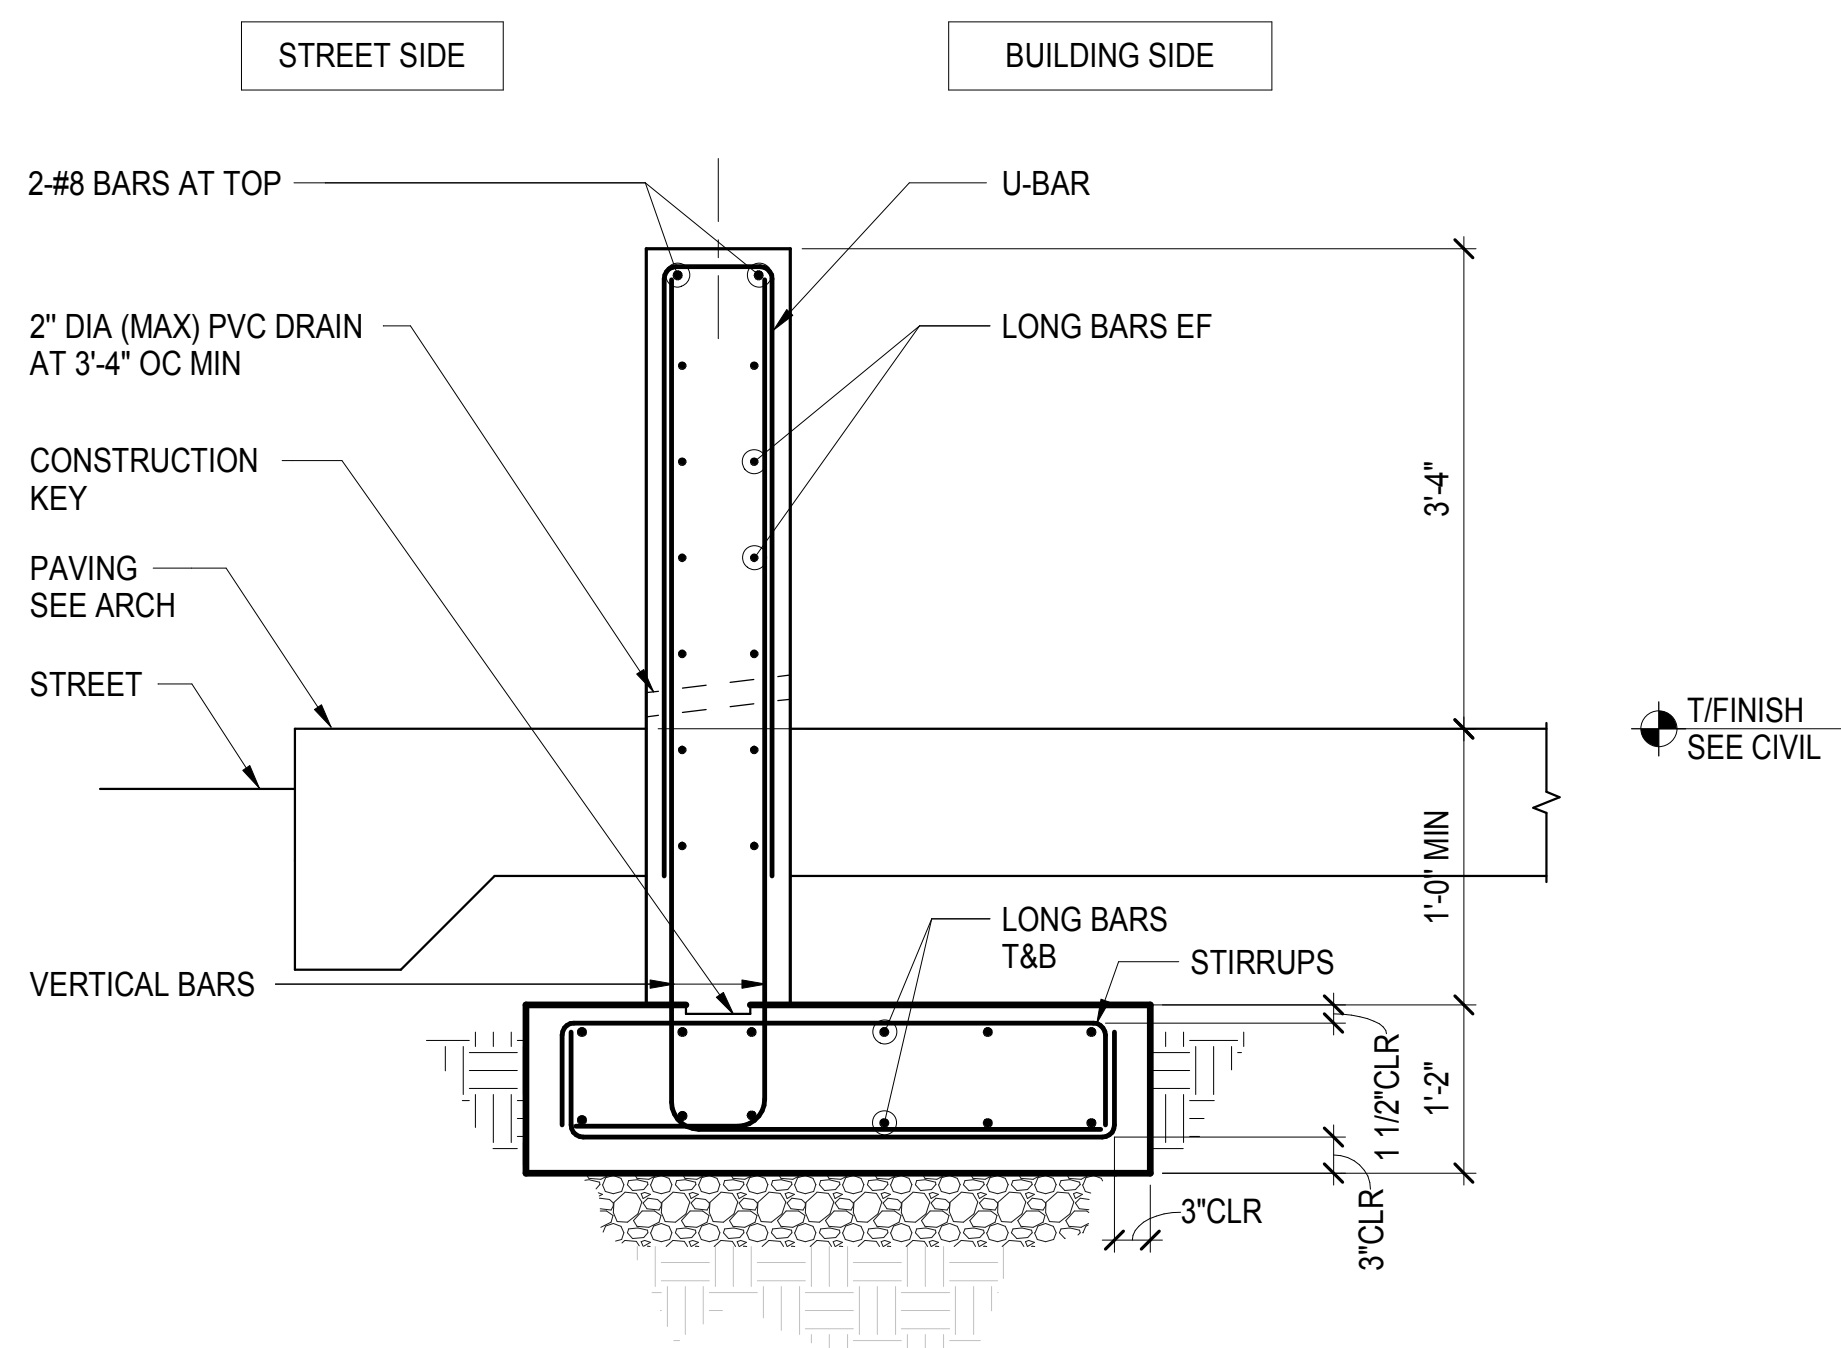

7 ANTI-RAM WALL SECTION

SCALE: 3/4" = 1'-0"

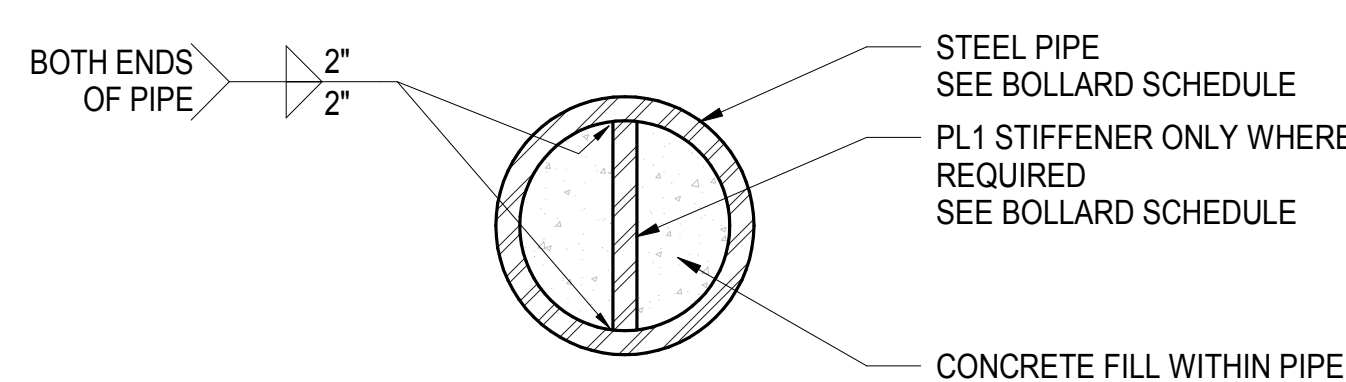

NOTES
1. INSTALL PIPE WITH STEEL PLATE ORIENTED PERPENDICULAR TO ADJACENT CURB LINE.

4 BOLLARD PIPE SECTION

SCALE: 1 1/2" = 1'-0"



CAVALIERS OPERATING COMPANY, LLC
1 CENTER COURT
CLEVELAND, OH 44115
646.625.3693

Gensler

S P O R T S

ARCHITECT
GENSLER
200 K ST NW, SUITE 200
WASHINGTON, DC 20006
Tel: 202.721.5000

ASSOCIATE ARCHITECT - INTERIORS
ROBERT P. ADAMSON
160 WEST FORT STREET, SUITE 400
DETROIT, MI 48226
Tel: 313.463.5151

STRUCTURAL ENGINEER
THORNTON TOMASETTI
51 MADISON AVENUE
NEW YORK, NY 10015-1603
Tel: 917.861.7800

MERPPP ENGINEER & LIGHTING (SPORTS)
SMITH SECORMAN REED, INC.
2805 SODO DRIVE
NASHVILLE, TN 37204
Tel: 615.383.1113

CIVIL ENGINEER
THE C/O.N. COURTNEY COMPANY
700 BETA DRIVE, SUITE 200
CLEVELAND, OH 44113

LIGHTING/EXTERIOR, SITE, INTERIOR, LANDSCAPE
OFFICE FOR VISUAL INTERACTION, INC.
40 WORTH STREET, SUITE 602
NEW YORK, NY 10013
Tel: 212.208.0800

TRAFFIC, PARKING & PEDESTRIAN ANALYSIS
CON SMITH
1400 WEST 8TH STREET, SUITE 150
CLEVELAND, OH 44113
Tel: 216.579.0404

EVENT PLANNING
VENUE SOLUTIONS GROUP
7700 PARCH COURT, SUITE 108
BRENTWOOD, TN 37027
Tel: 615.322.5454

VERTICAL TRANSPORTATION
VAN DER BEEK & ASSOCIATES
120 EAGLE ROCK AVENUE, SUITE 310
EAST MANASSAS, VA 20108
Tel: 973.894.6220

PROTECTIVE DESIGN ENGINEER
THORNTON TOMASETTI
300 N. WABASH AVENUE, SUITE 1500
CHICAGO, IL 60611-7622
Tel: 312.596.2000

NOT FOR
CONSTRUCTION

SCHEMATIC DESIGN 09/14/2018
ISSUE DATE

DRAWING TITLE
DETAILS

SEAL & SIGNATURE DATE 09/14/2018
PROJECT NO. C18172.00
DRAWN BY NS
CHECKED BY TMD
DOR NO.
DRAWING NUMBER

PD-012.10